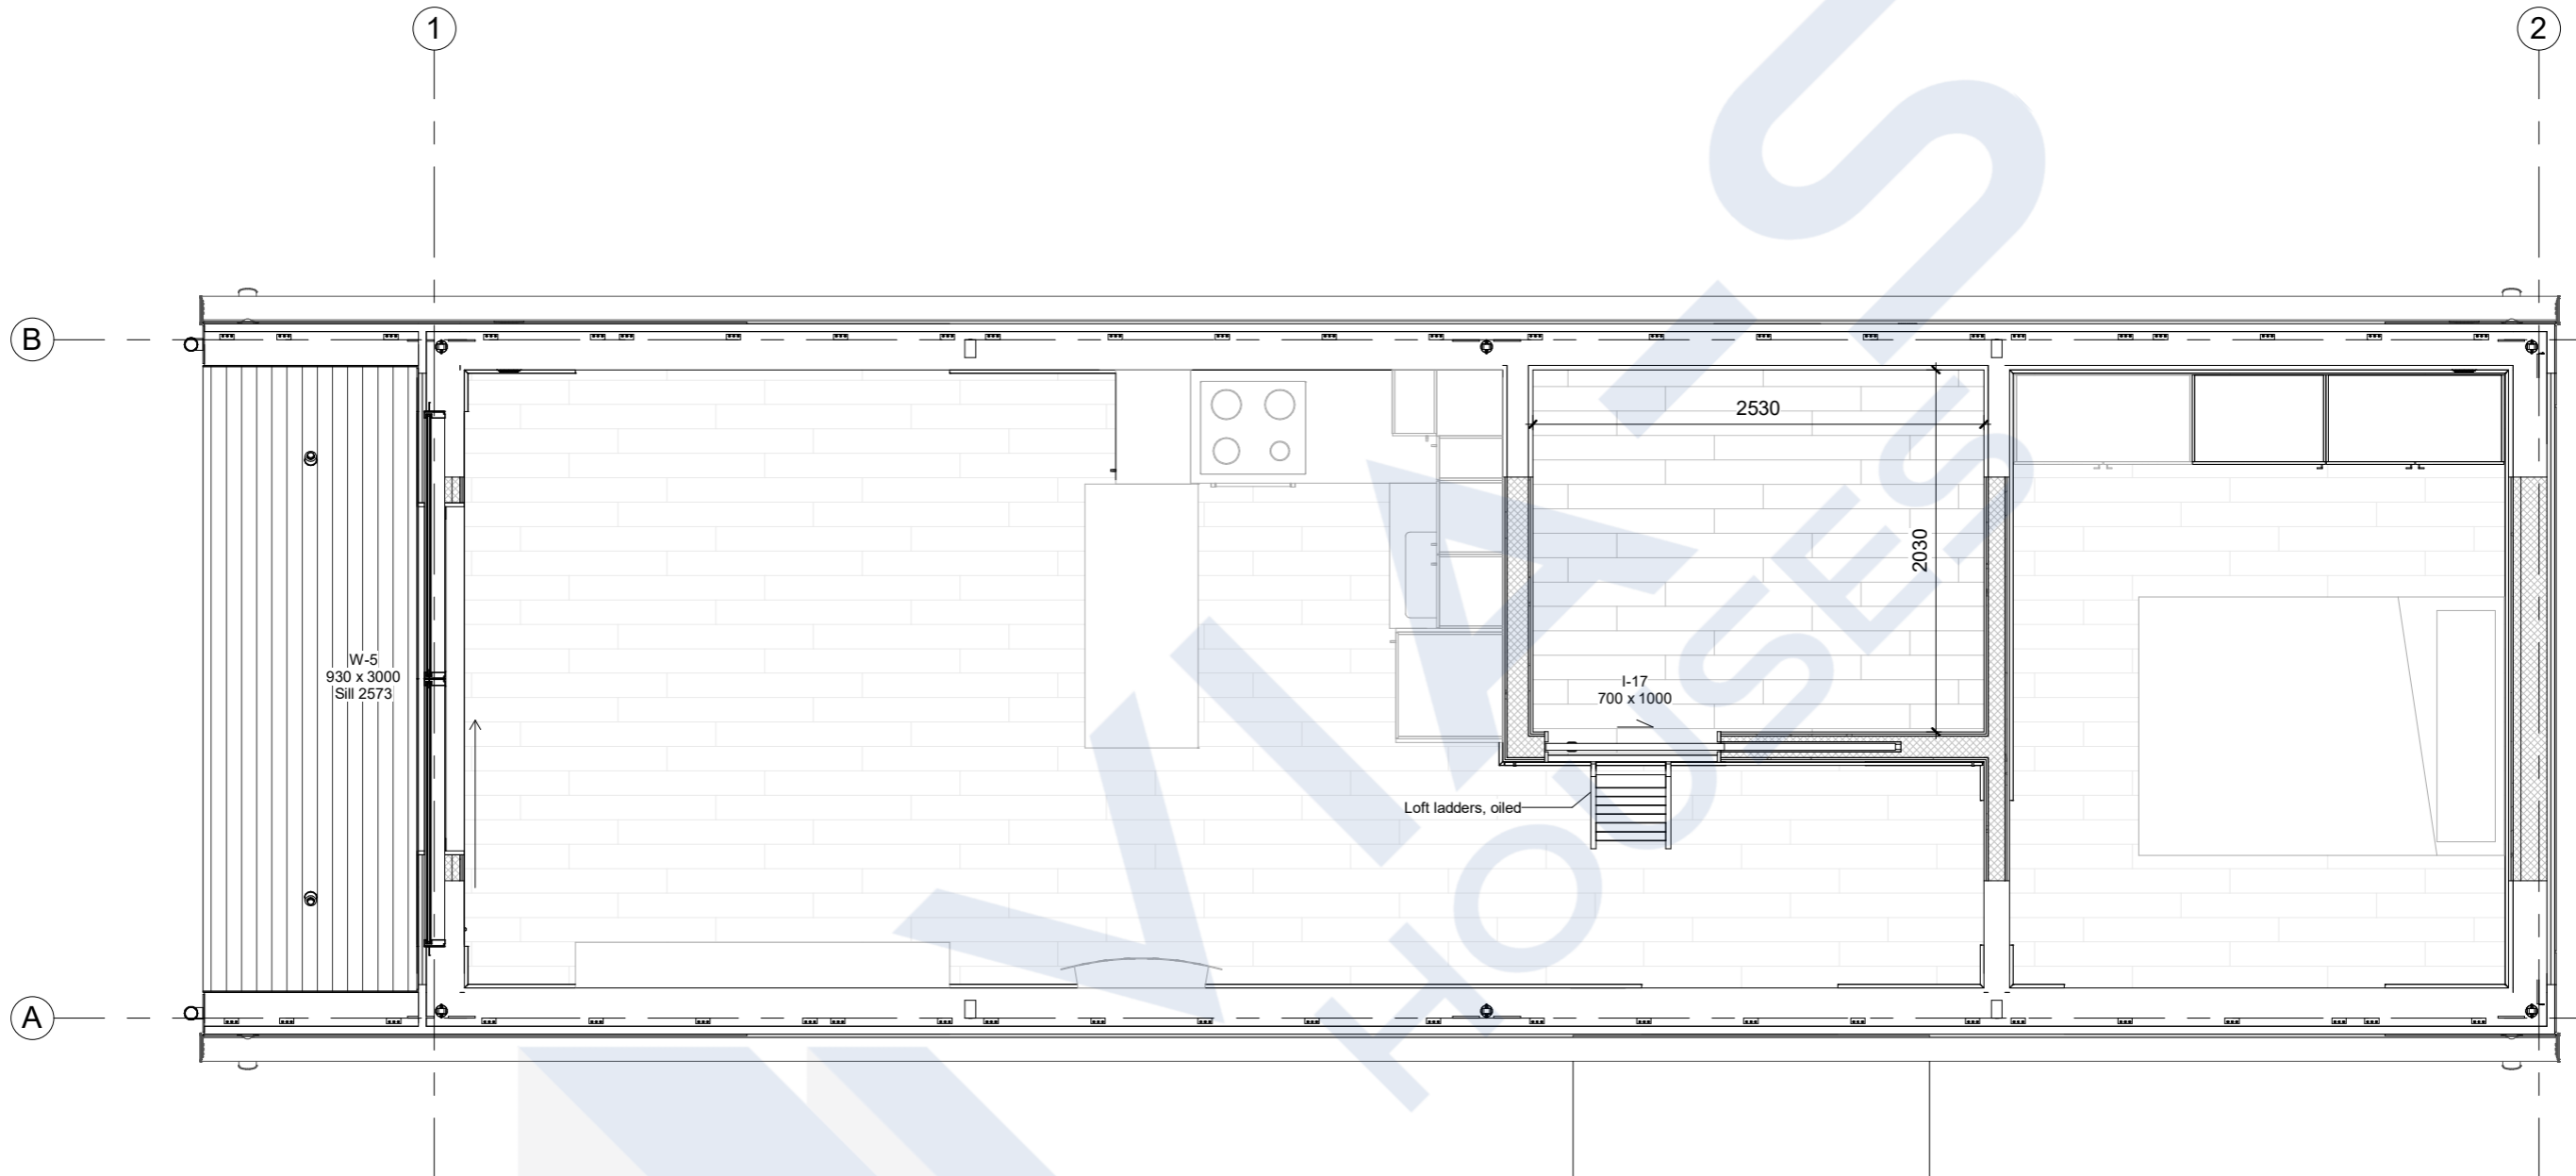

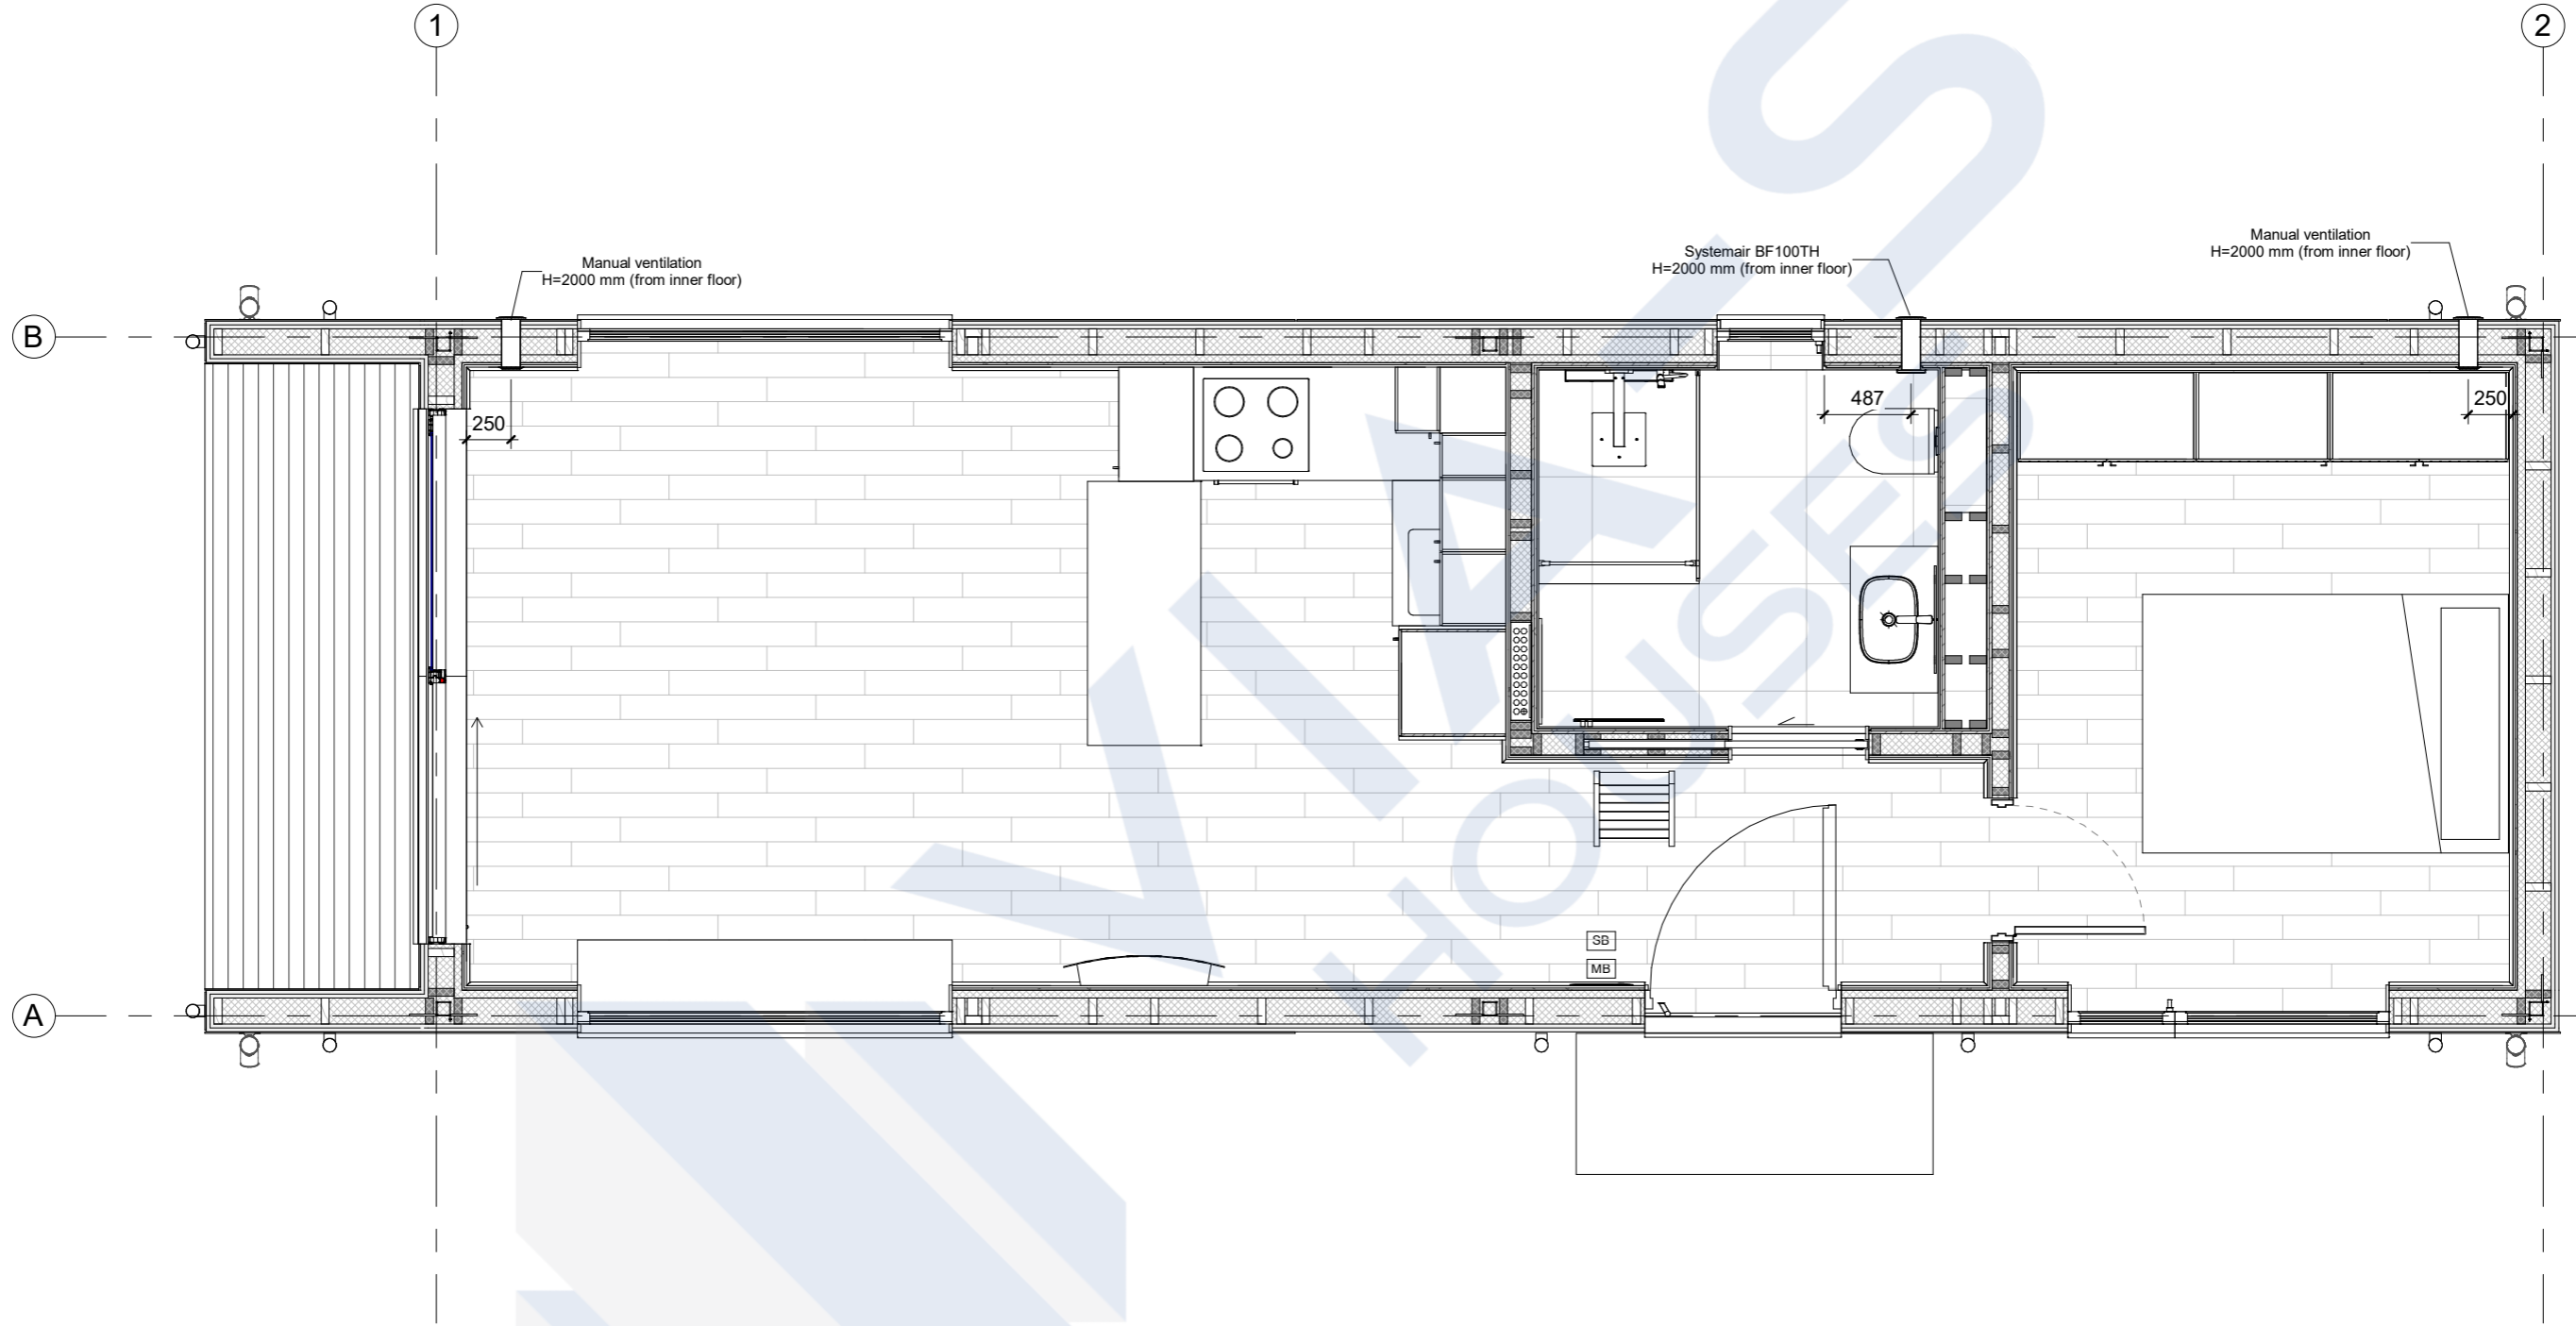

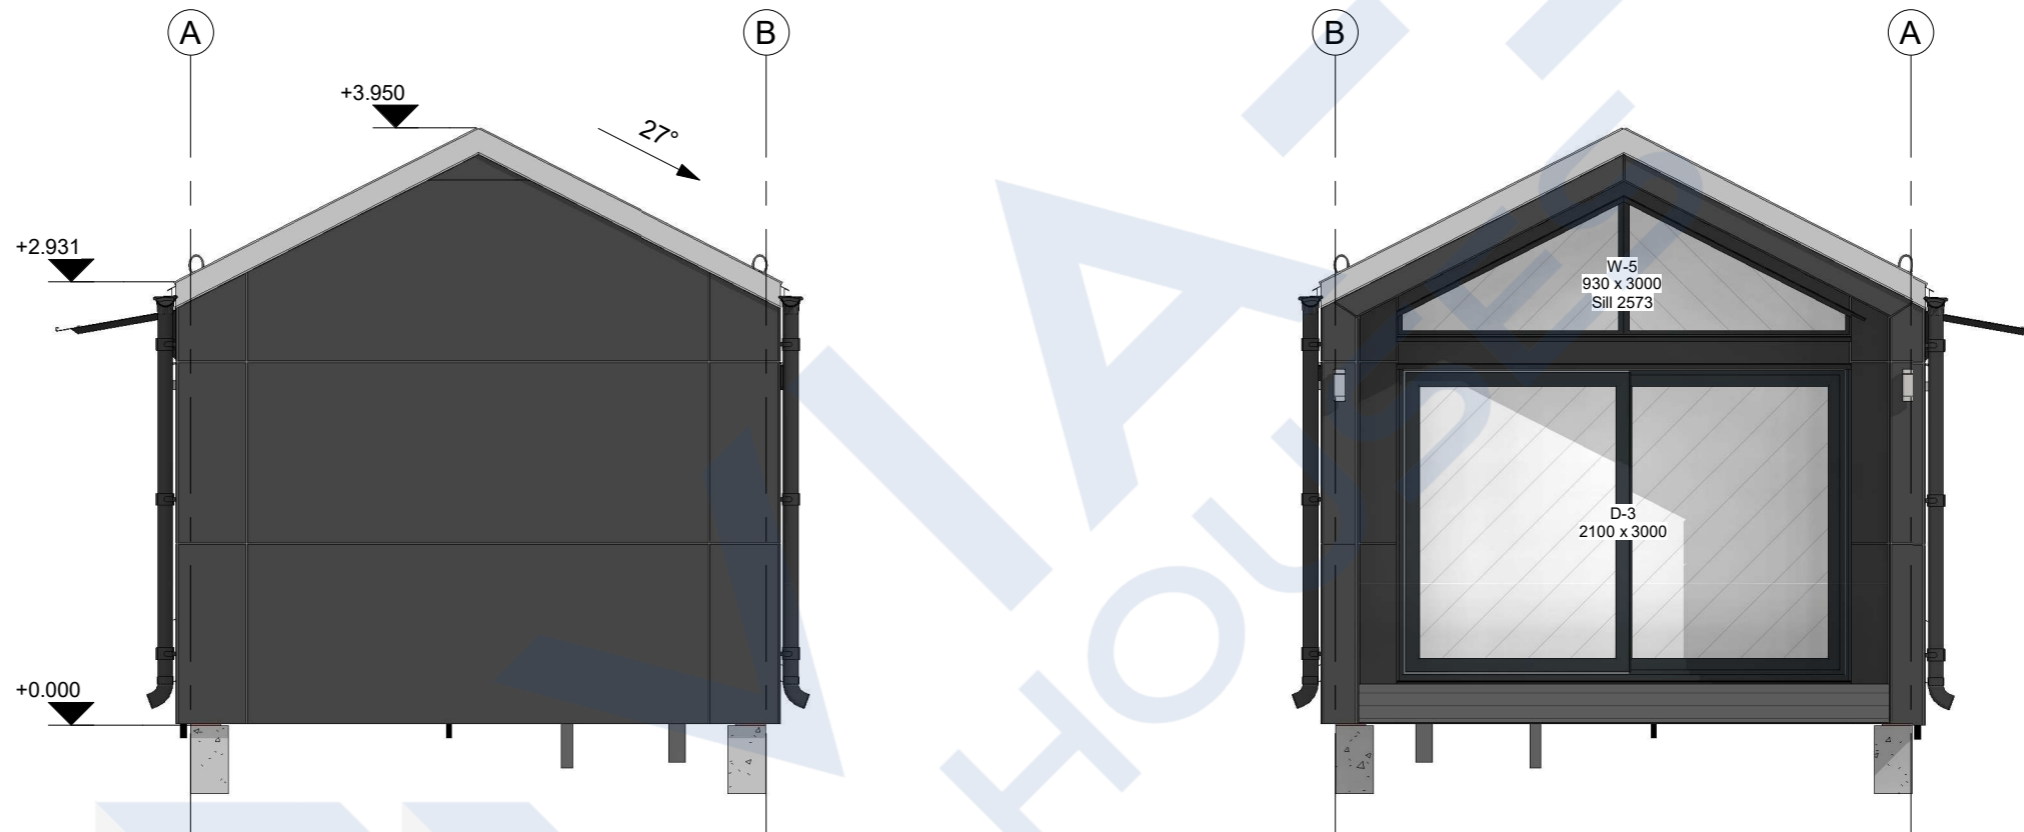
		Project:		53 m2	
				1582	
Developed	Elands Lauva	04.10.2022	Module Plan	Stage	Page
Plot data		22.11.2022		Scale 1 : 40	BP




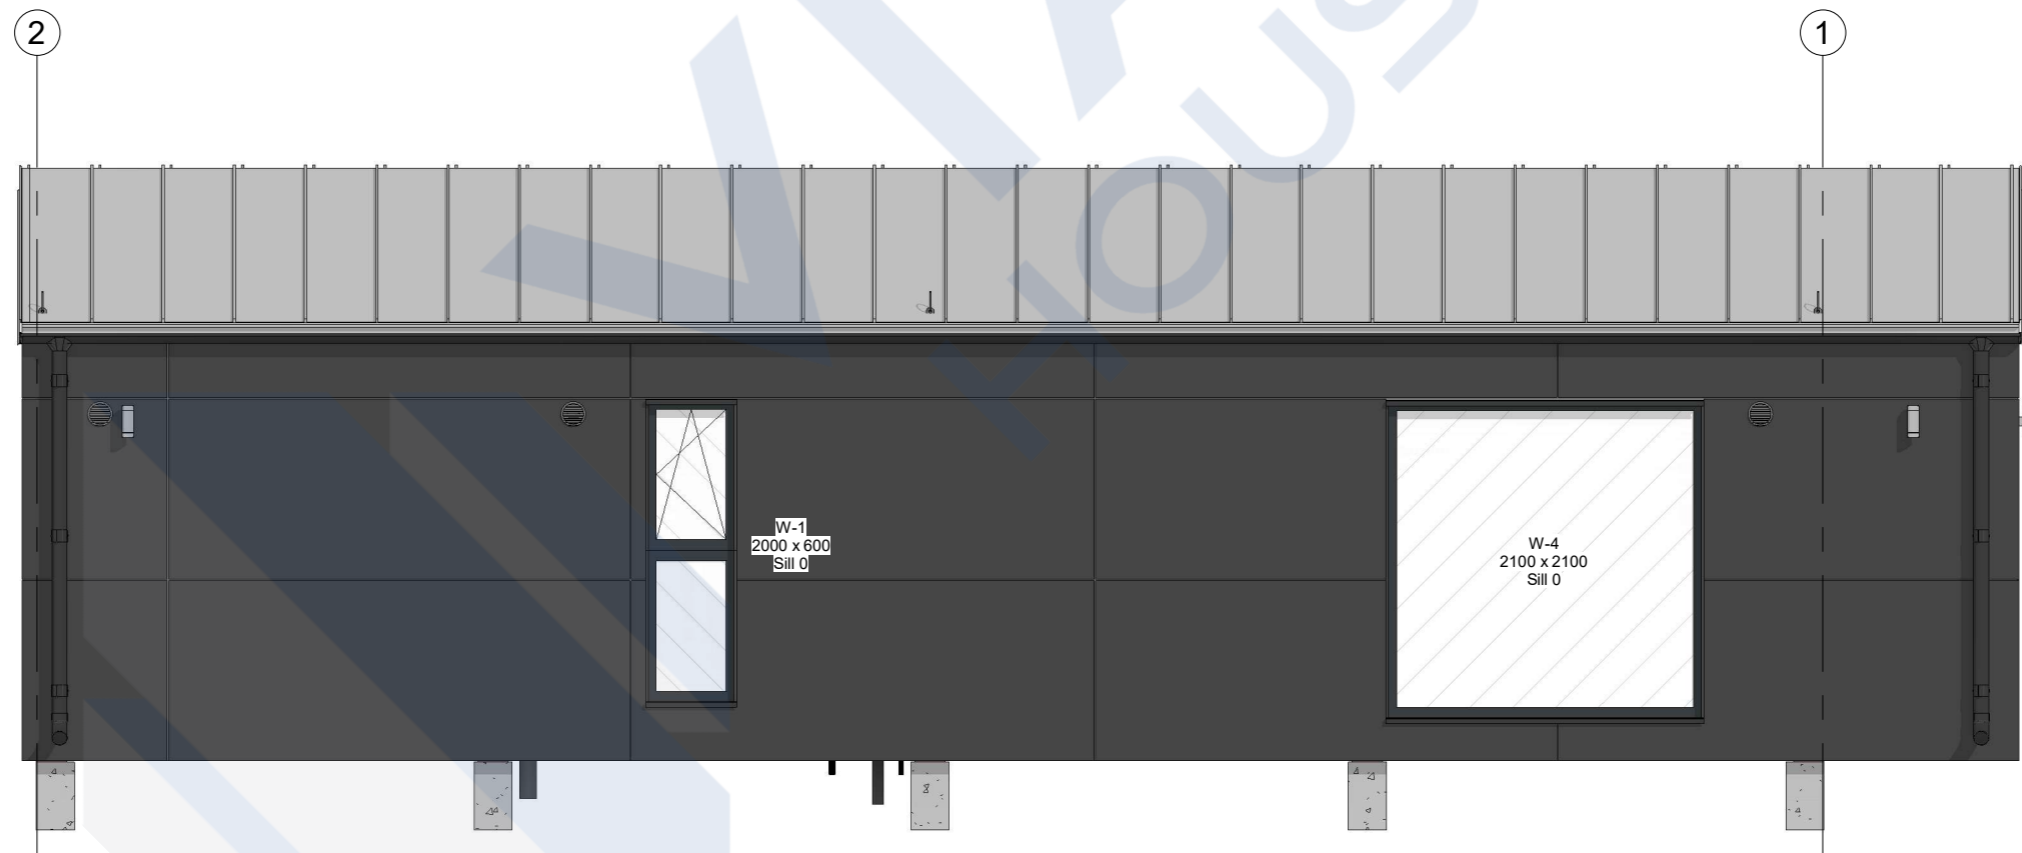
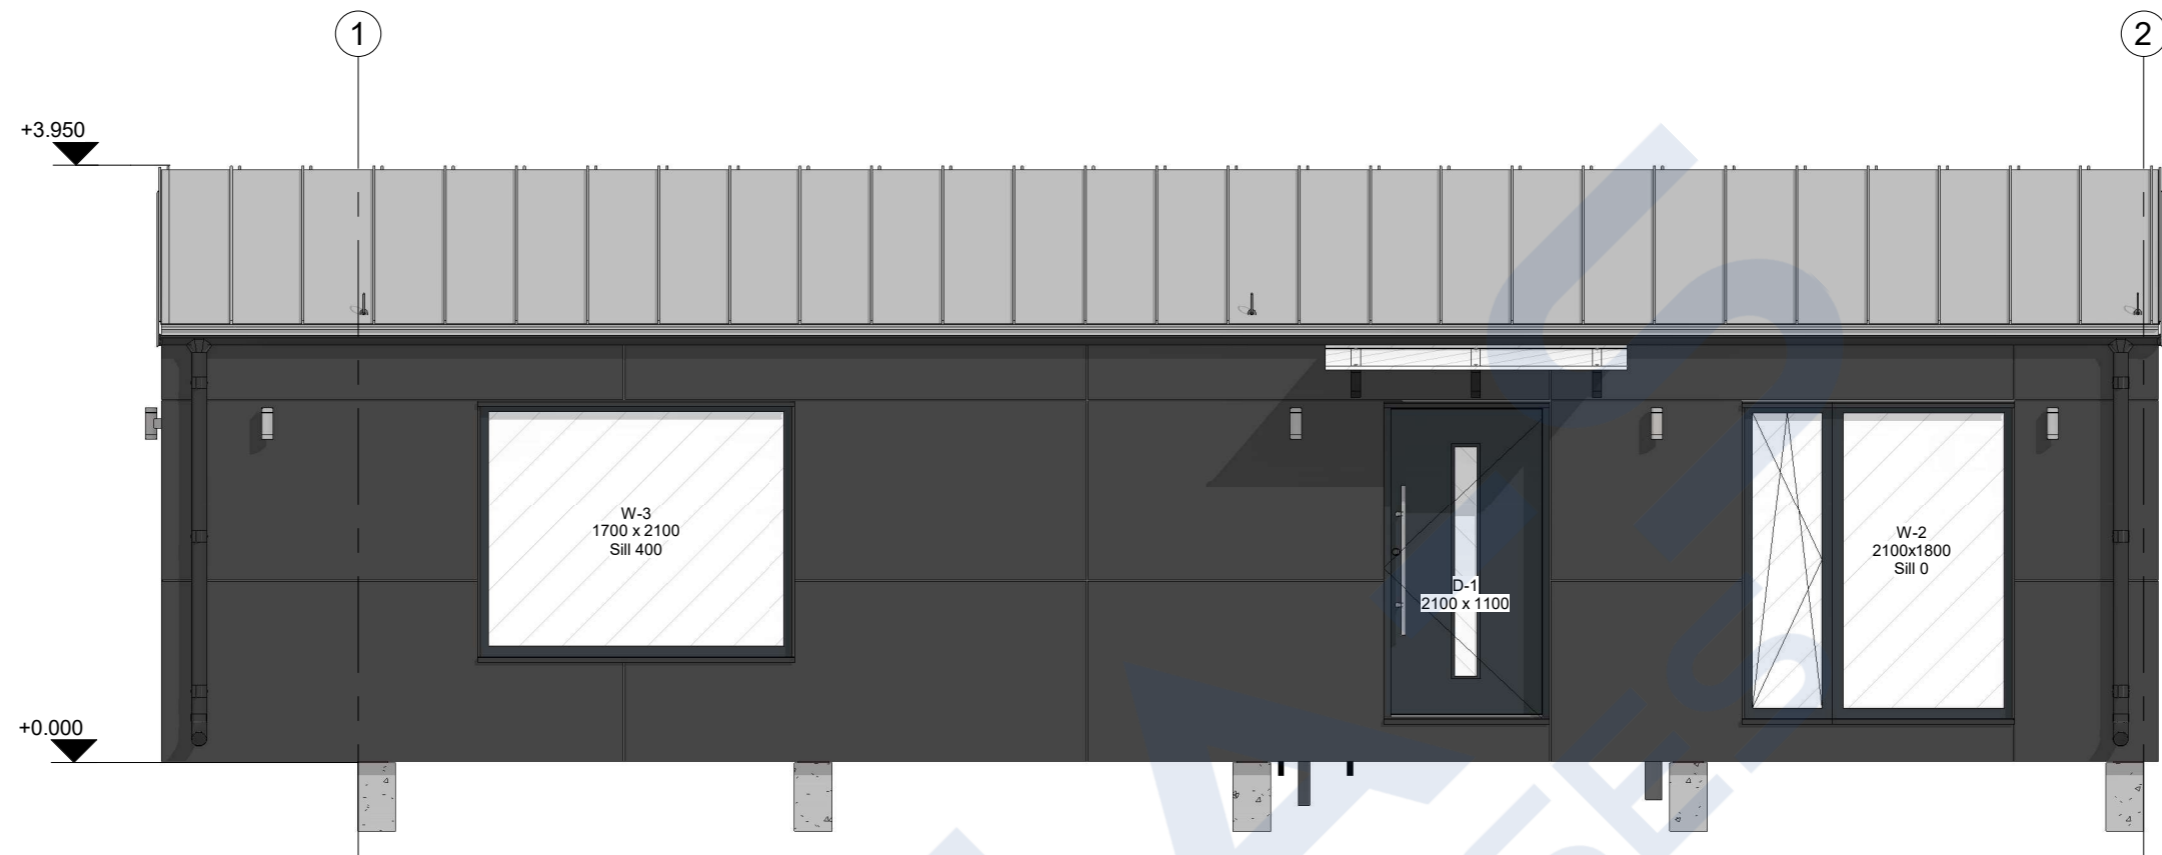
		Project:		53 m2	
				1582	
Developed	Elands Lauva	04.10.2022	Loft Plan	Stage	Page
Plot data		22.11.2022		Scale 1 : 40	BP




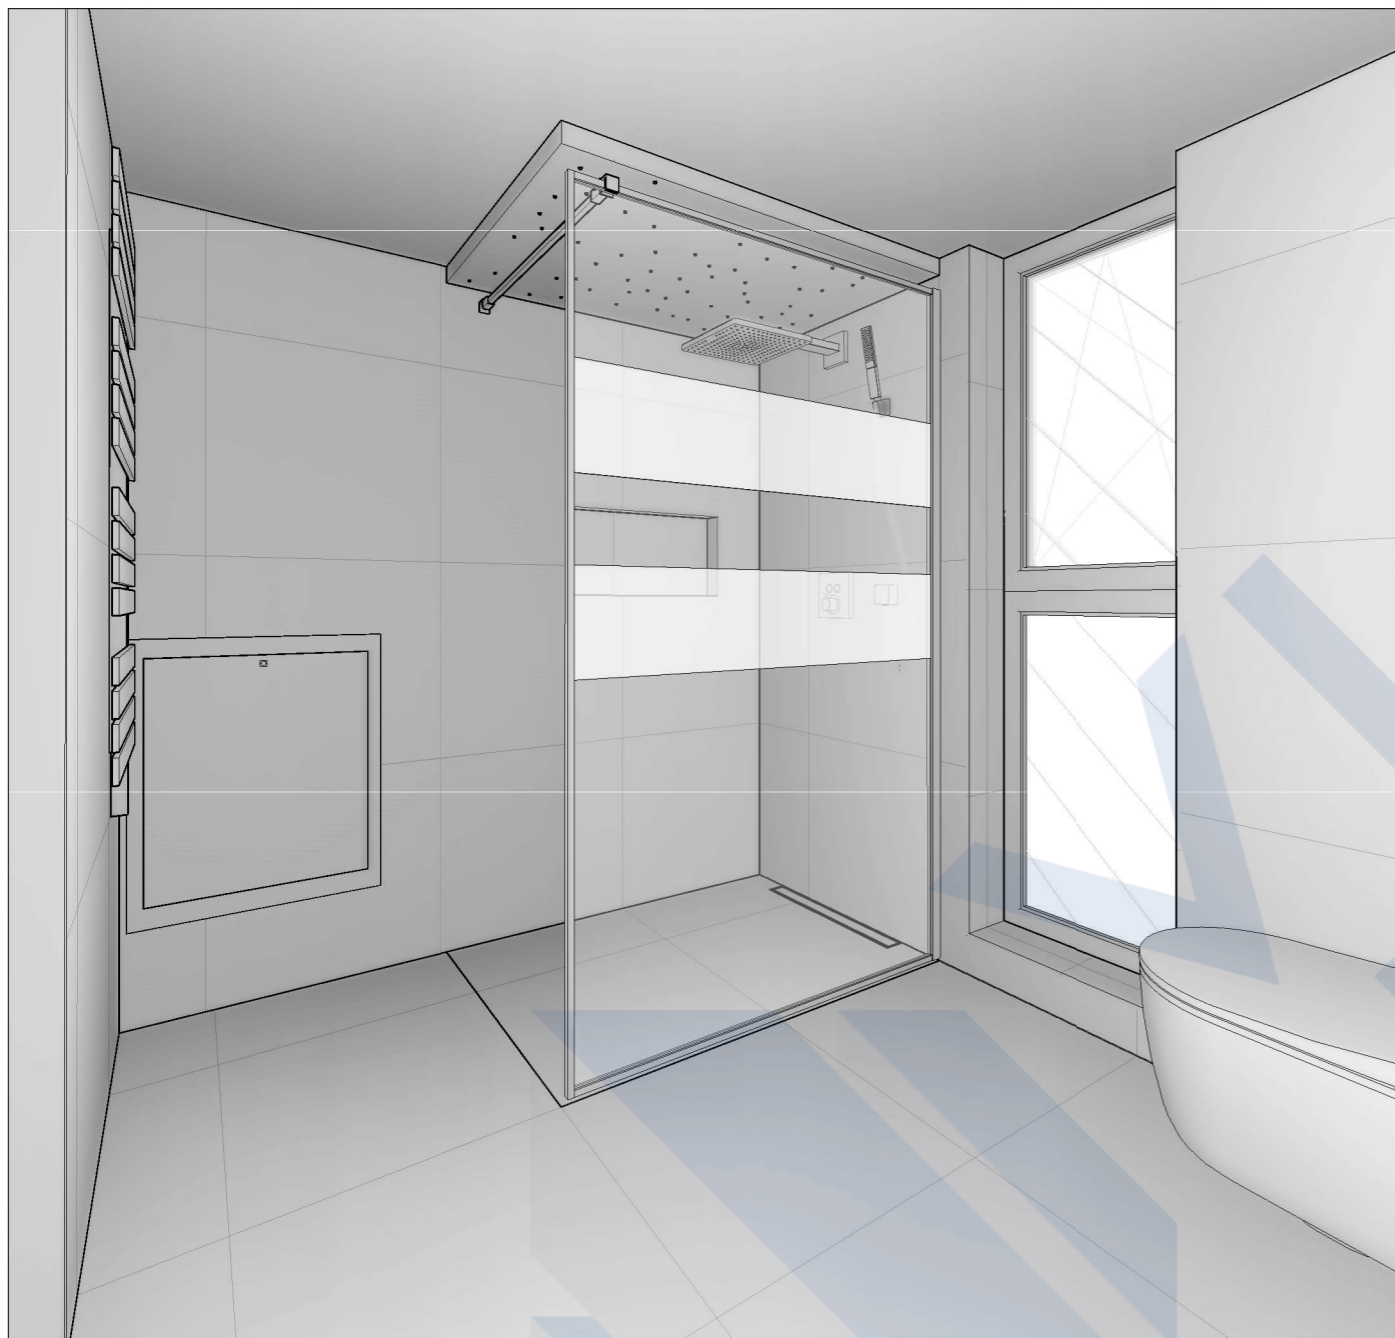
		Project:		53 m2	
				1582	
Developed	Elands Lauva	04.10.2022	Ventilation Plan	Stage	Page
Plot data		22.11.2022		Scale 1 : 40	BP




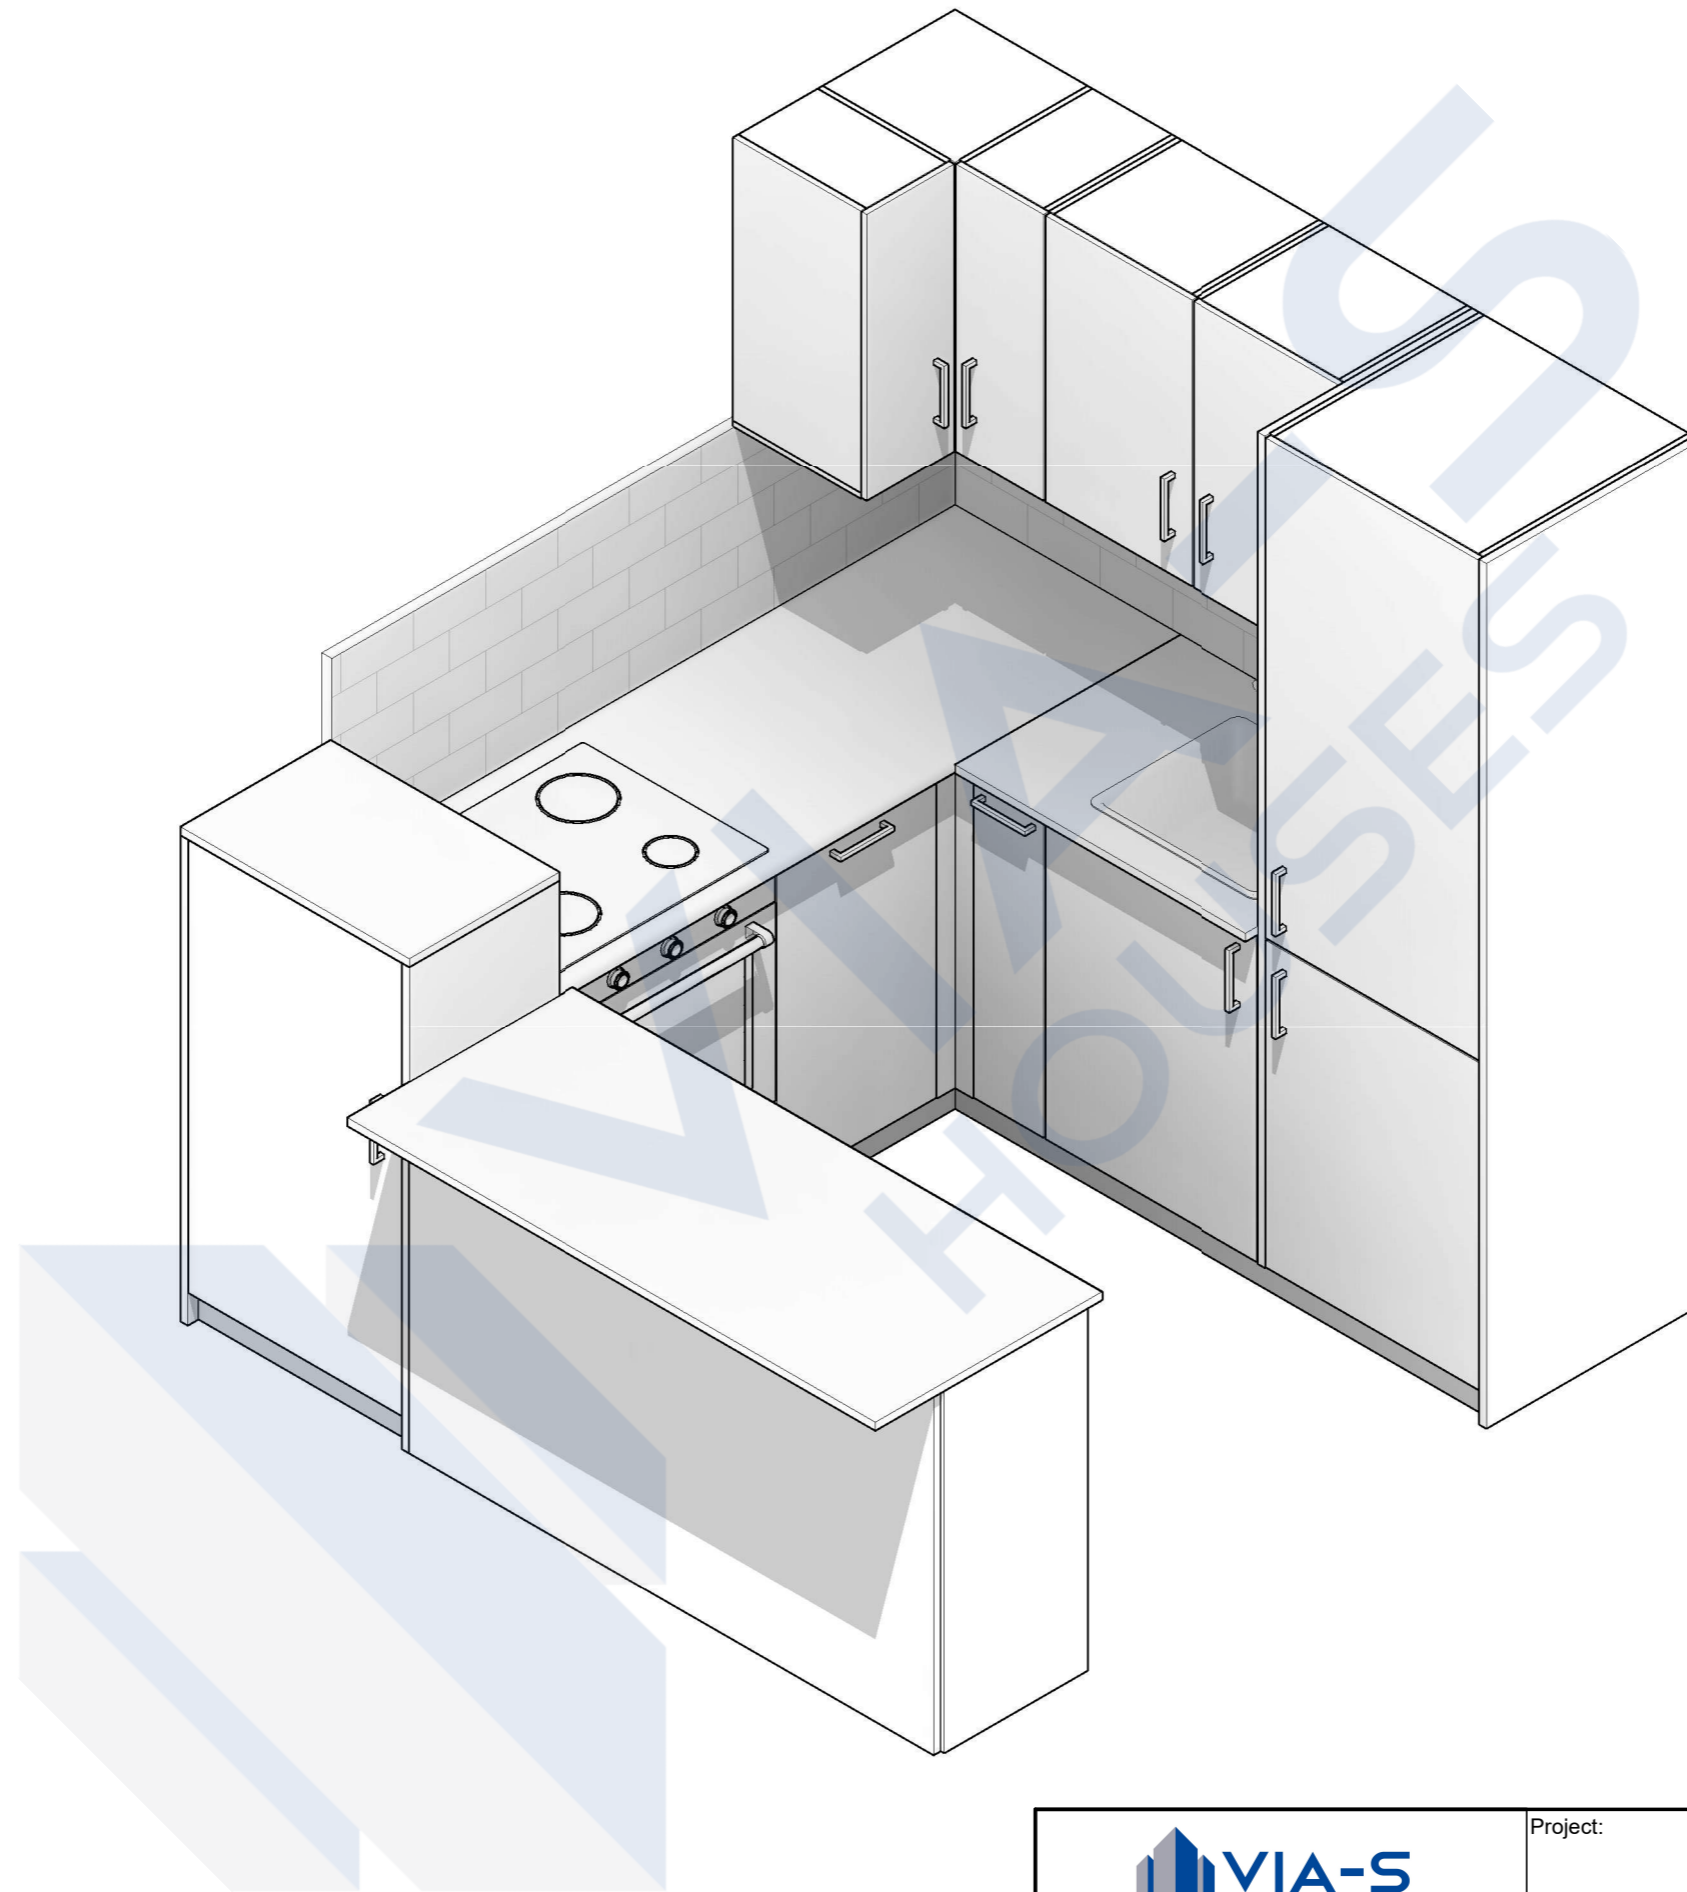
		Project:		53 m2	
				1582	
Developed	Elands Lauva	04.10.2022	Facades A-B, B-A	Stage	Page
				BP	AR-11
Plot data		22.11.2022	Scale 1 : 50		




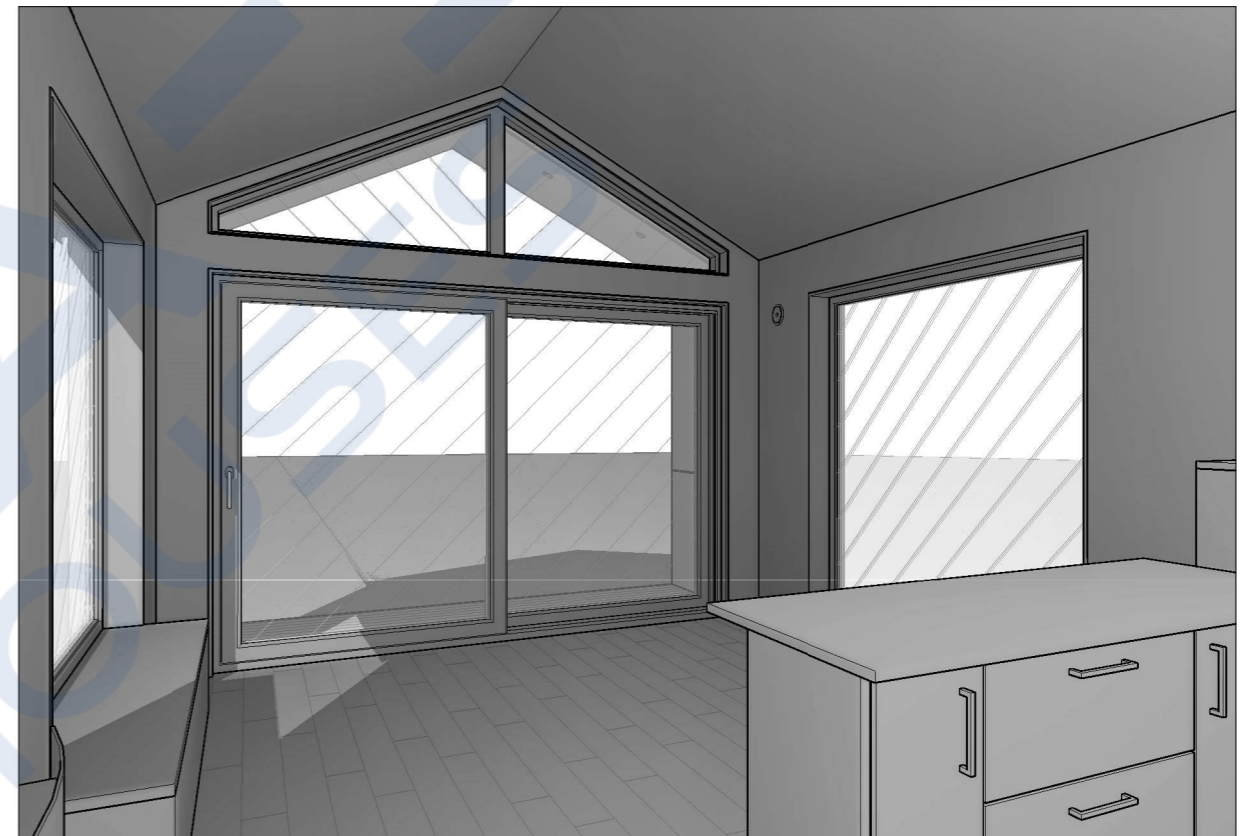
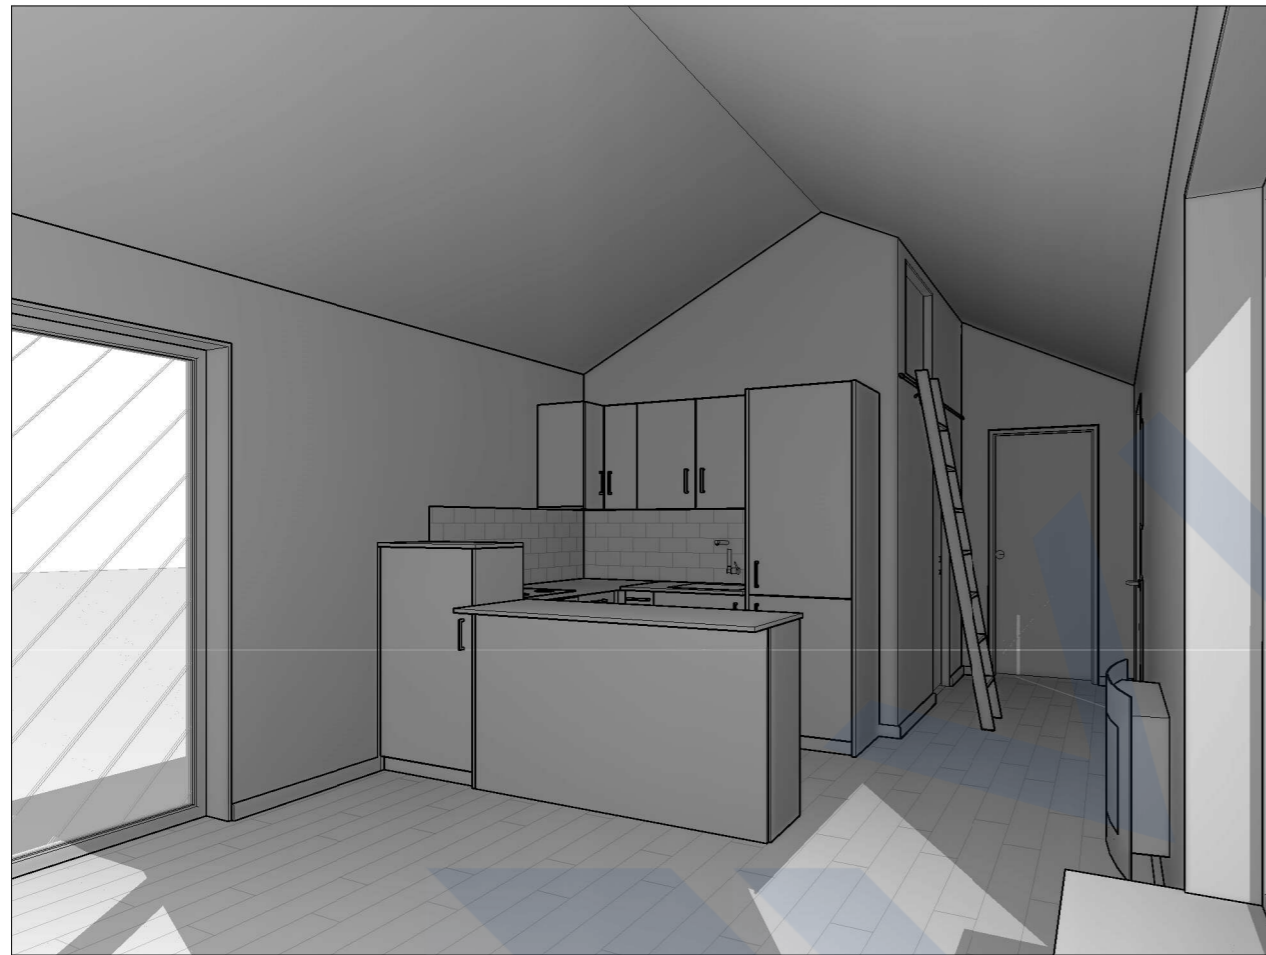
		Project:		53 m2	
				1582	
Developed	Elands Lauva	04.10.2022	Facades 1-2, 2-1	Stage	Page
Plot data		22.11.2022		Scale 1 : 50	BP




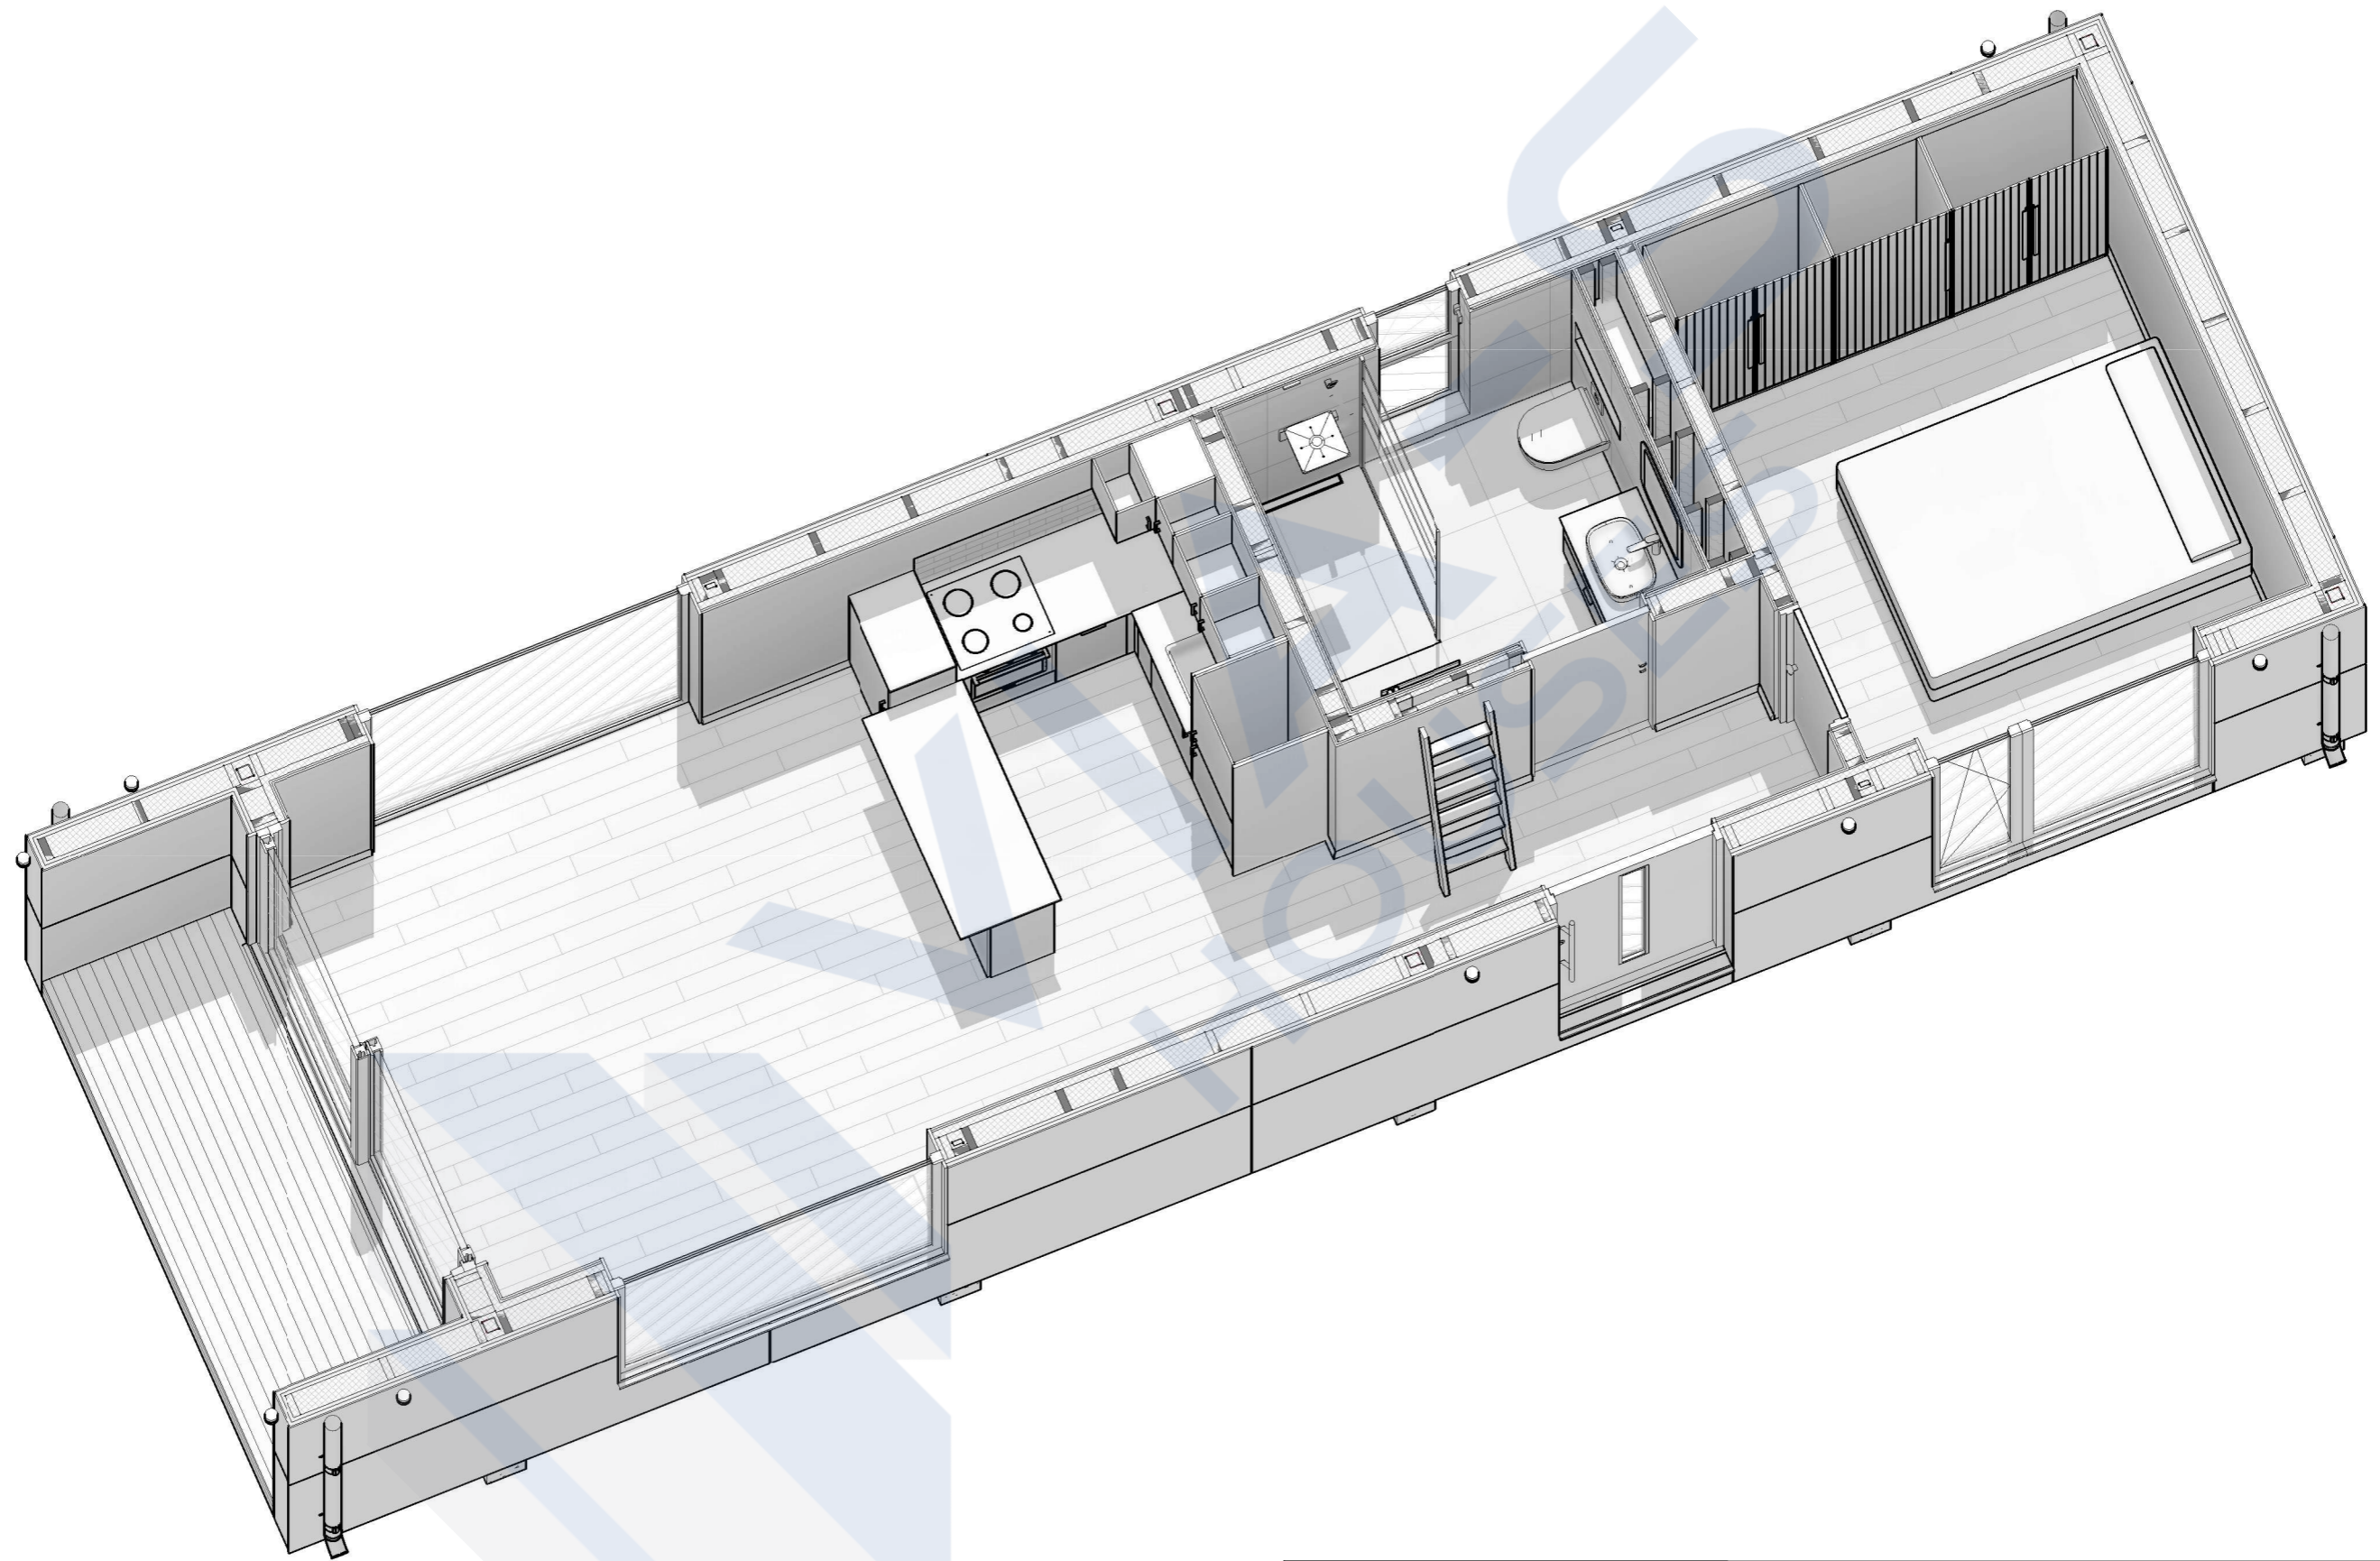
				Project:		53 m ²	
						1582	
Developed	Elands Lauva	04.10.2022	Bathroom V1, V2			Stage	Page
						BP	AR-15
Plot data		22.11.2022	Scale				




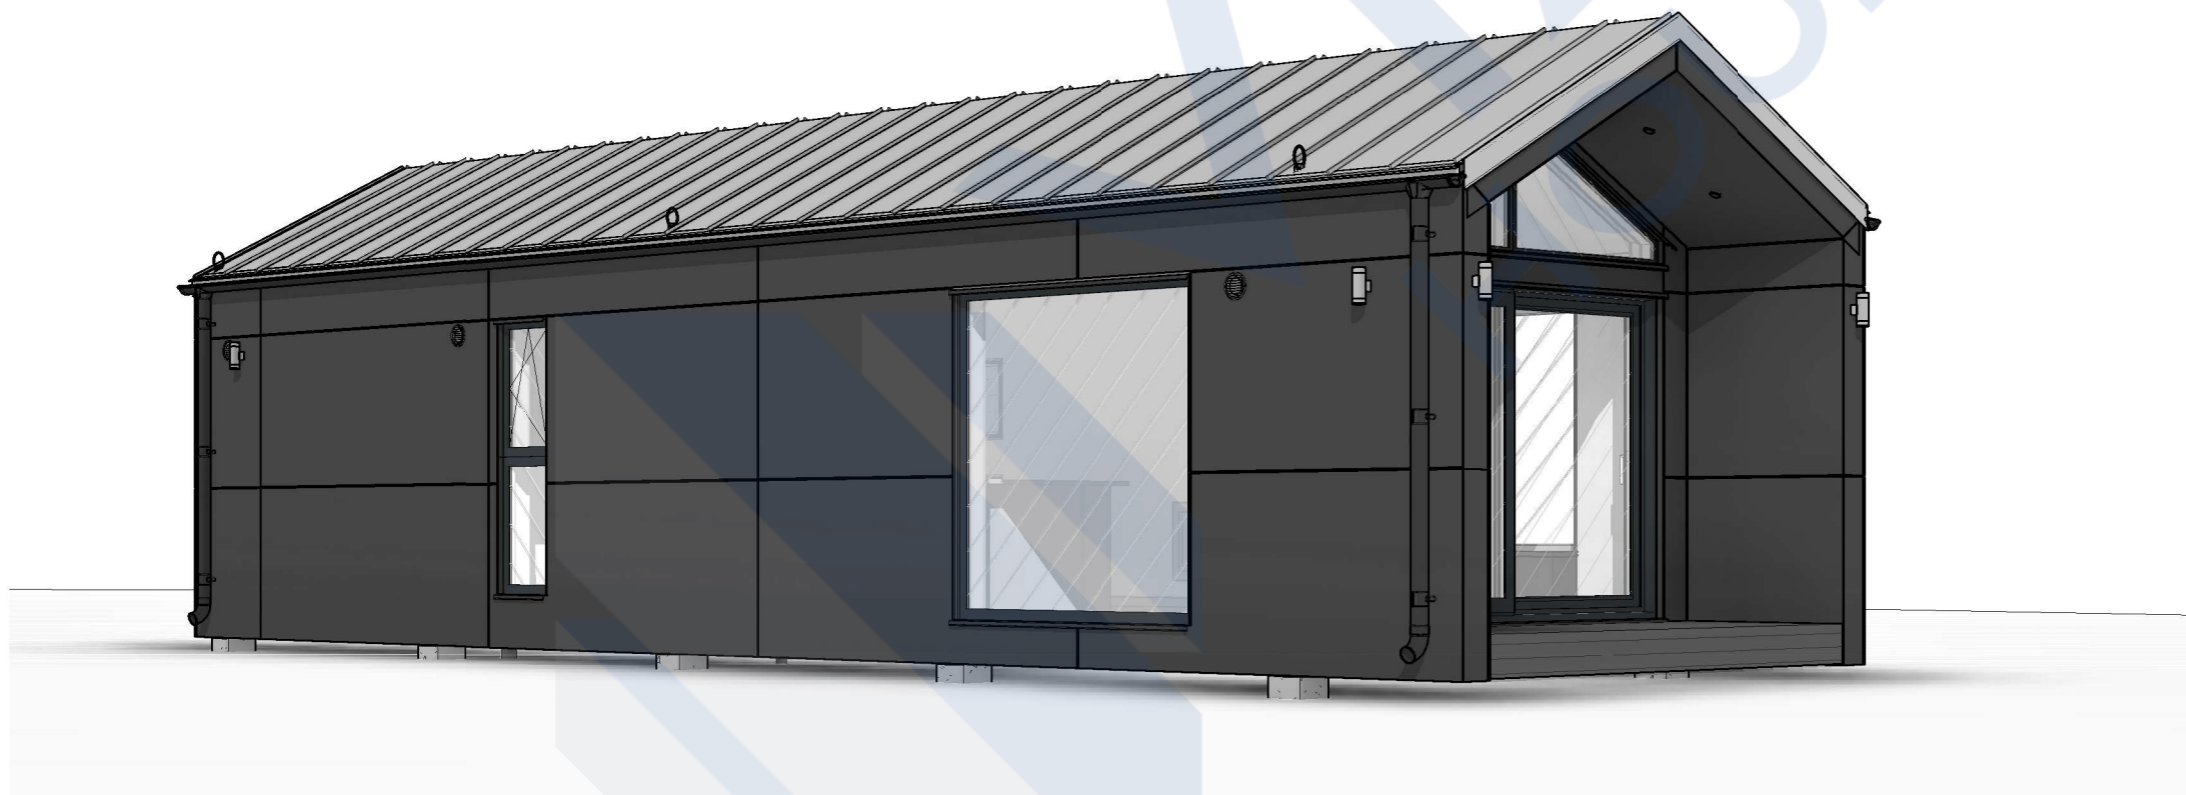
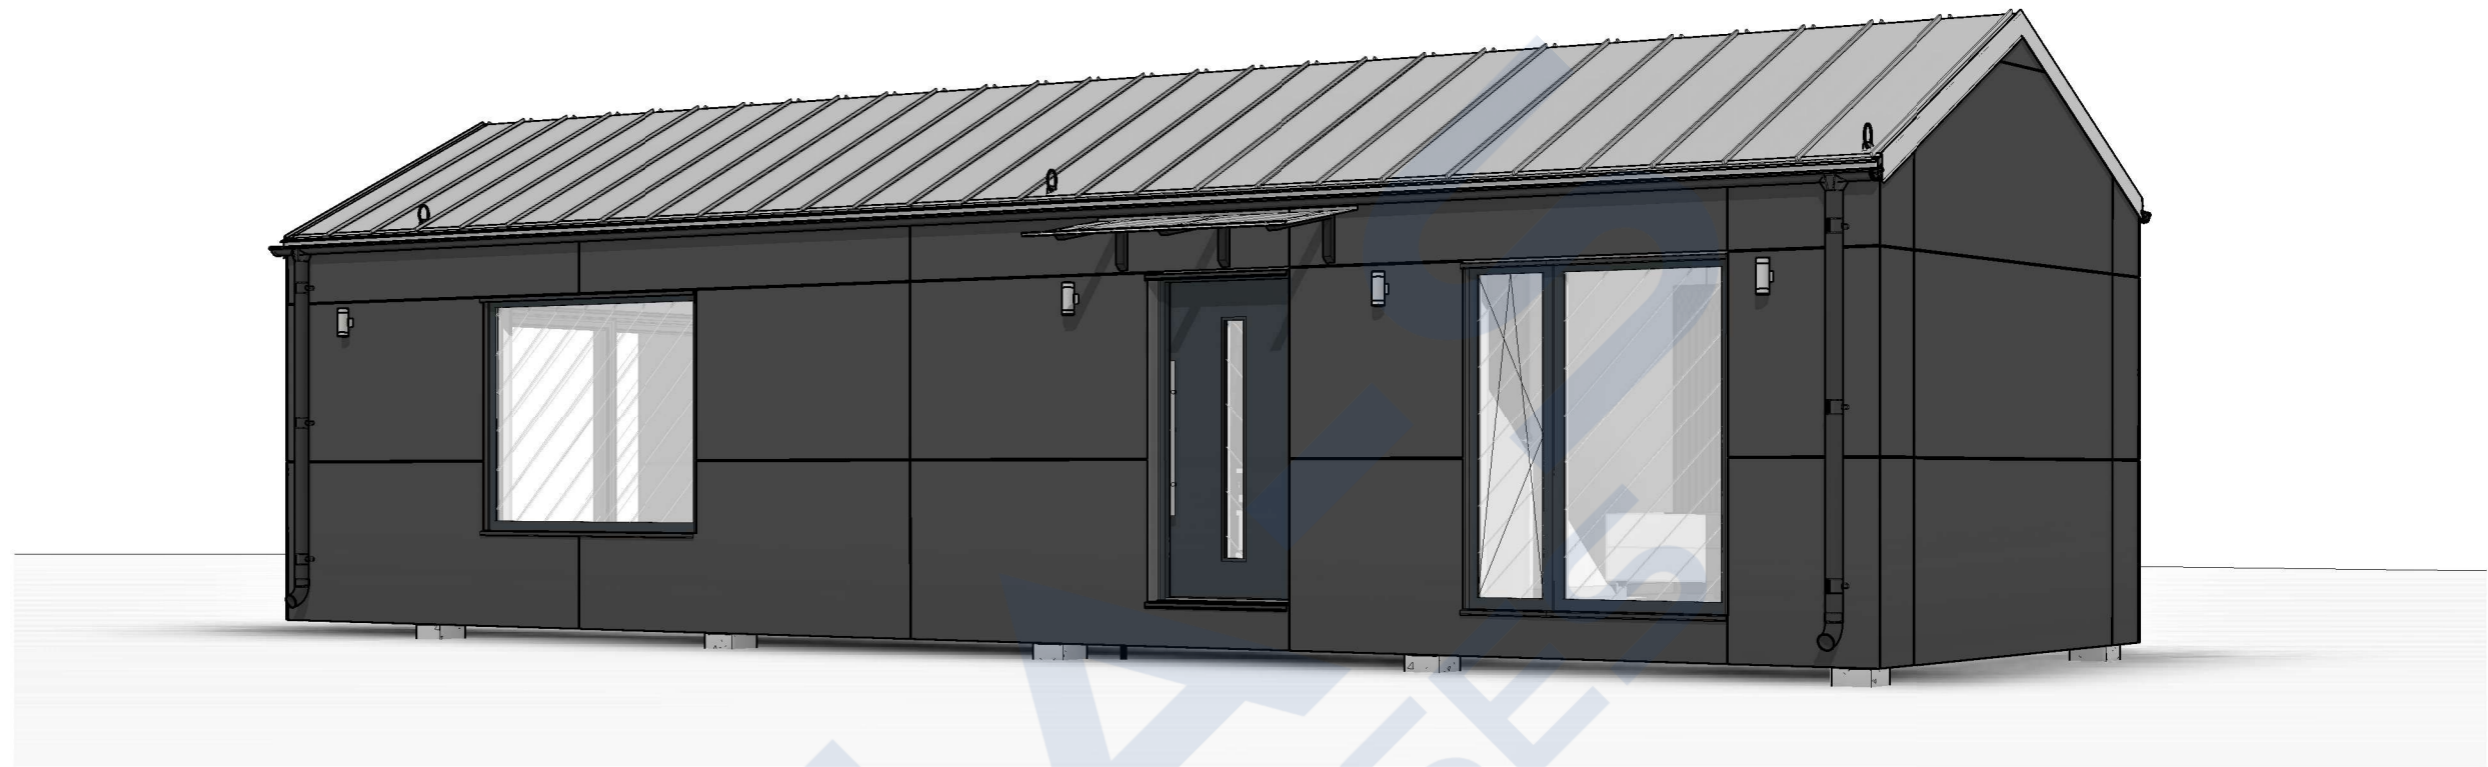
				Project:		53 m2
						1582
Developed	Elands Lauva	04.10.2022	Kitchen 3D		Stage	Page
					BP	AR-17
Plot data		22.11.2022	Scale			




				Project:		53 m2	
						1582	
Developed	Elands Lauva		04.10.2022	Room V1, V2		Stage	Page
						BP	AR-18
Plot data			22.11.2022	Scale			



				Project:		53 m2
						1582
Developed	Elands Lauva	04.10.2022	3D Plan		Stage	Page
Plot data		22.11.2022			Scale	BP



				Project:		53 m2
						1582
Developed	Elands Lauva	04.10.2022	Visualization 1, 2		Stage	Page
					BP	AR-20
Plot data		22.11.2022	Scale			